

















 









All features are approximate and are subject to clarification by a detailed topographical survey, statutory service enquiries and confirmation of the legal boundaries.




The controlled version of this drawing should be viewed in dwf or pdf format not dwg or other file formats.

Do not scale the drawing, always use the figured dimensions, all dimensions to be checked on site, discrepancies are to be recorded in writing to the Project Architect/Structural Engineer




FIRE STRATEGY

- | | |
|---|--|
|  | 3 HOUR FULLY MAINTAINED EMERGENCY LIGHT |
|  | PANEL BOLT |
|  | DRY POWDER EXTINGUISHER (10LB OR 20LB) |
|  | WATER EXTINGUISHER |
|  | CO2 EXTINGUISHER |
|  | FOAM EXTINGUISHER |
|  | FIRE BLANKET |
|  | AREA COVERED BY HEAT DETECTORS |
|  | INDICATOR PANEL |
|  | 3 HOUR NON MAINTAINED EMERGENCY LIGHT |
|  | FIRE ALARM CALL POINT |
|  | BELL |
|  | ILLUMINATED EXIT SIGN |
|  | EXIT DIRECTIONAL SIGN |
|  | AREA COVERED BY SMOKE DETECTORS |
|  | AFR MULTIPURPOSE EXTINGUISHER 5.5 LITRE 85%
ELECTRICALLY NON-CONDUCTIVE 13A + 113B RATING |
|  | BURGLAR ALARM |
|  | FIRE ALARM |
|  | CONTROL PANEL |
|  | FIRE DOOR SIGNS PUSH |
|  | FLASHING BEACON DISABLED |
|  | SOUNDER/BRIGHT |
|  | DISABLED PULL CORD |
|  | 1/2hr fire resisting self closing door or kept locked shut when not in use |
|  | 1hr fire resisting self closing door or kept locked shut when not in use |
|  | Self closing device |


CCTV system

-  CCTV CAMERA EXTERNAL
 CCTV SCREEN
 CCTV CAMERA INTERNAL






Intruder Alarm System

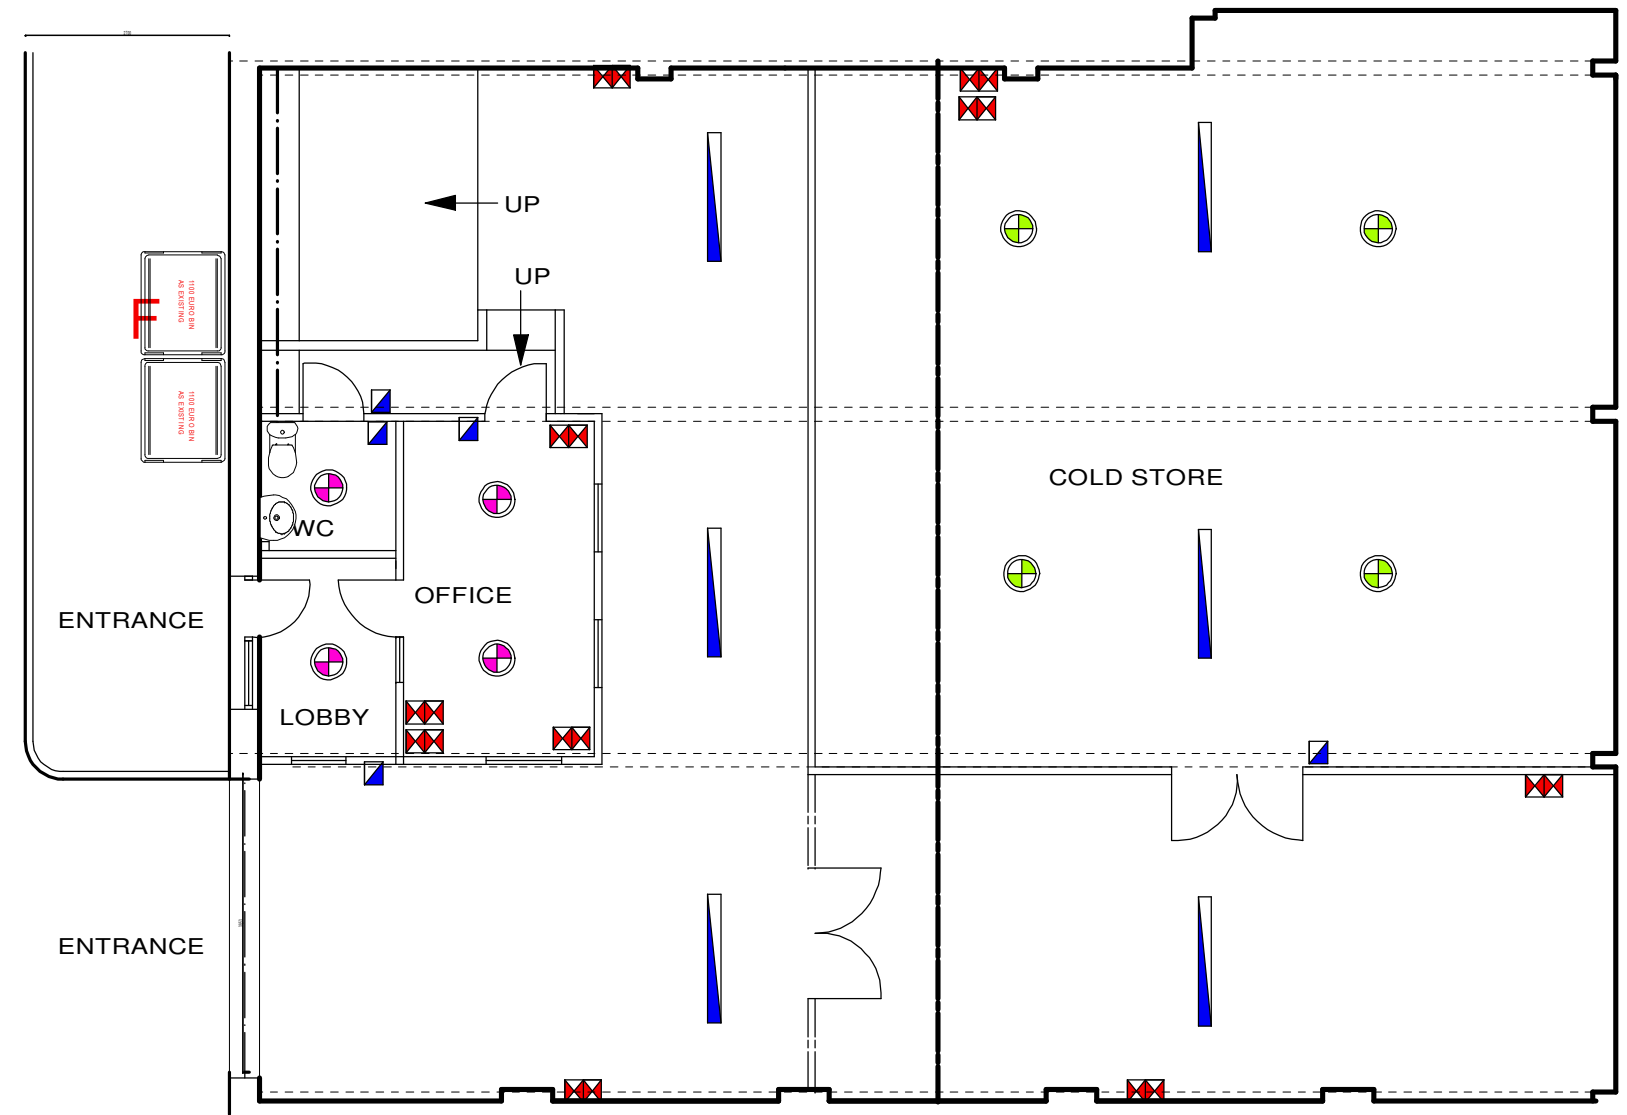-  MOVEMENT DETECTOR
 DOOR CONTACT
 EXTERNAL SOUNDER

RED EDGE INDICATES LICENSED AREA



ELECTRICAL LEGEND

-  DOUBLE PLUG SOCKET
-  LIGHT SWITCH
-  CEILING LIGHTS
-  LARGE COMMERCIAL CEILING LIGHTS
-  STORE CEILING LIGHTS

	Date	Revisions
Bartlett ID 25 Coquet Terrace Heaton Newcastle upon Tyne NE6 5LE E : simon@bartlettid.uk		
Project: 6 BARRRELS Unit 1 Northumberland Street North Shields, NE30 1DS		
Drawing Title:		
LICENSING PLANS		
Scale: 1:100 @ A2		
Drg No: 2025-300	Rev B	
Date: 26/02/25	Drawn by SAB	